



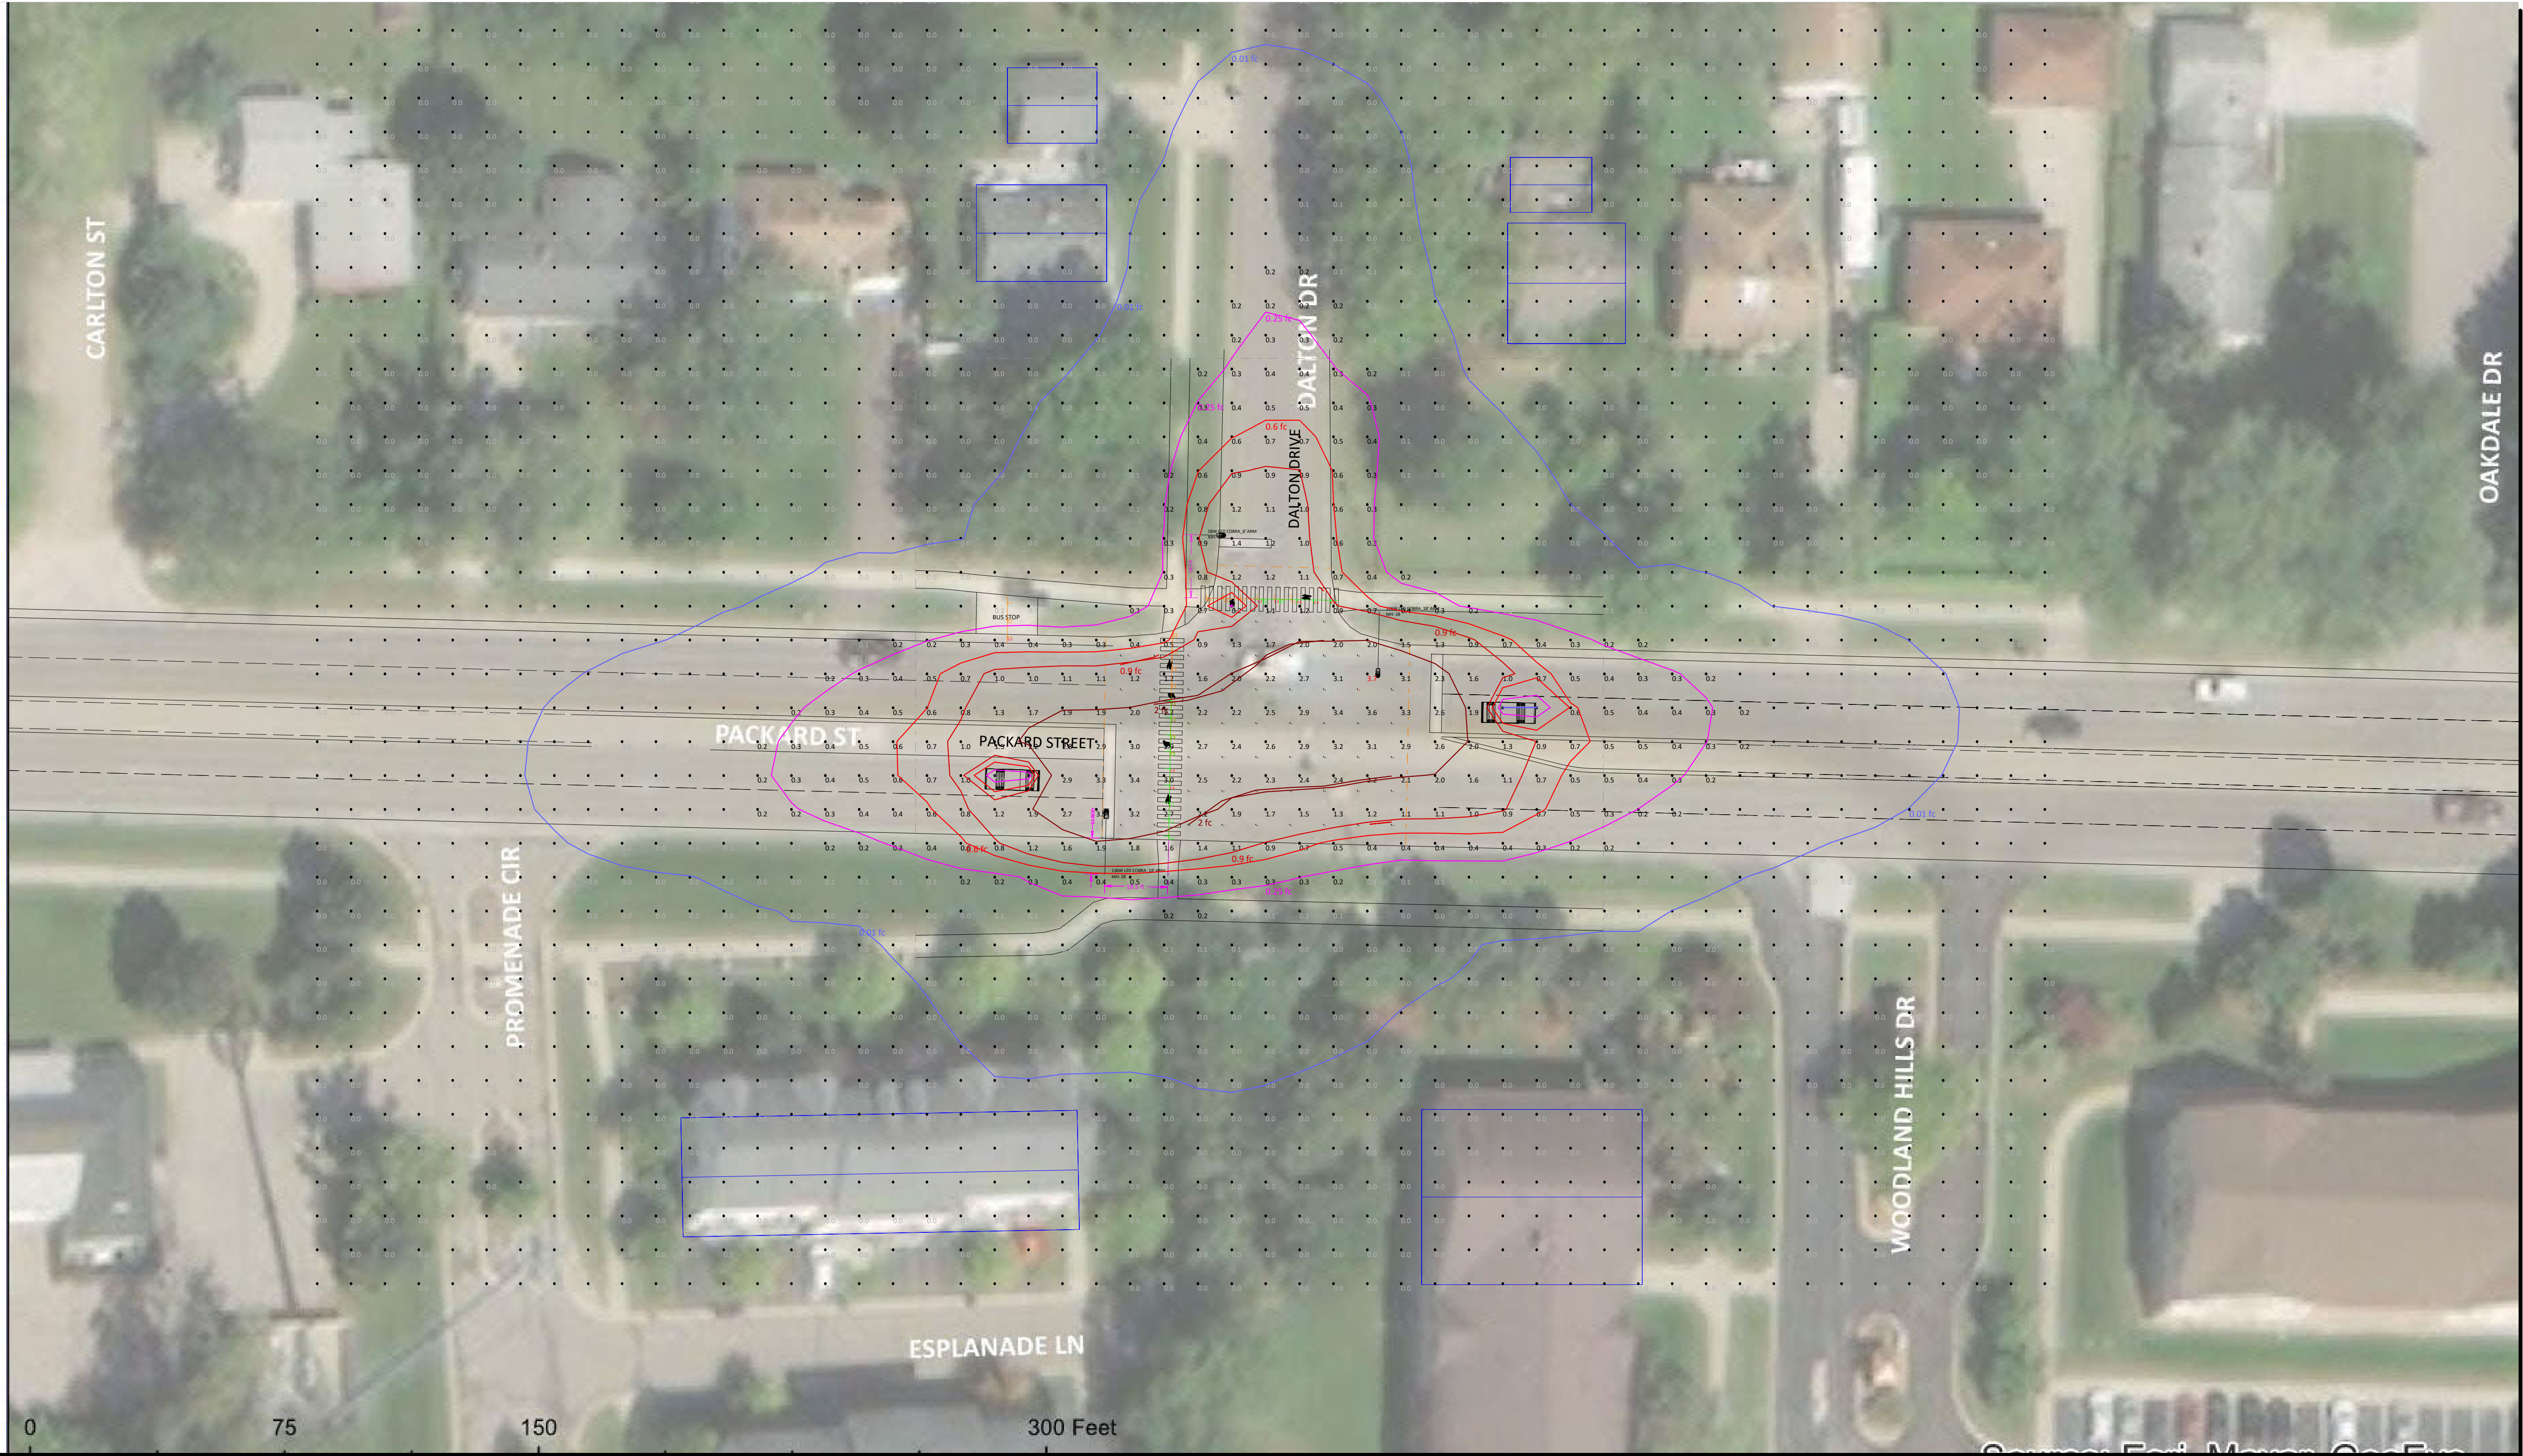

SITE PLAN - OVERALL VIEW
Scale: 1 inch= 25 Ft.

Isoline Legend	
Illuminance (Fc)	
Color	Value
■	0.01
■	0.25
■	0.6
■	0.9
■	2


Revisions	
#	Comments

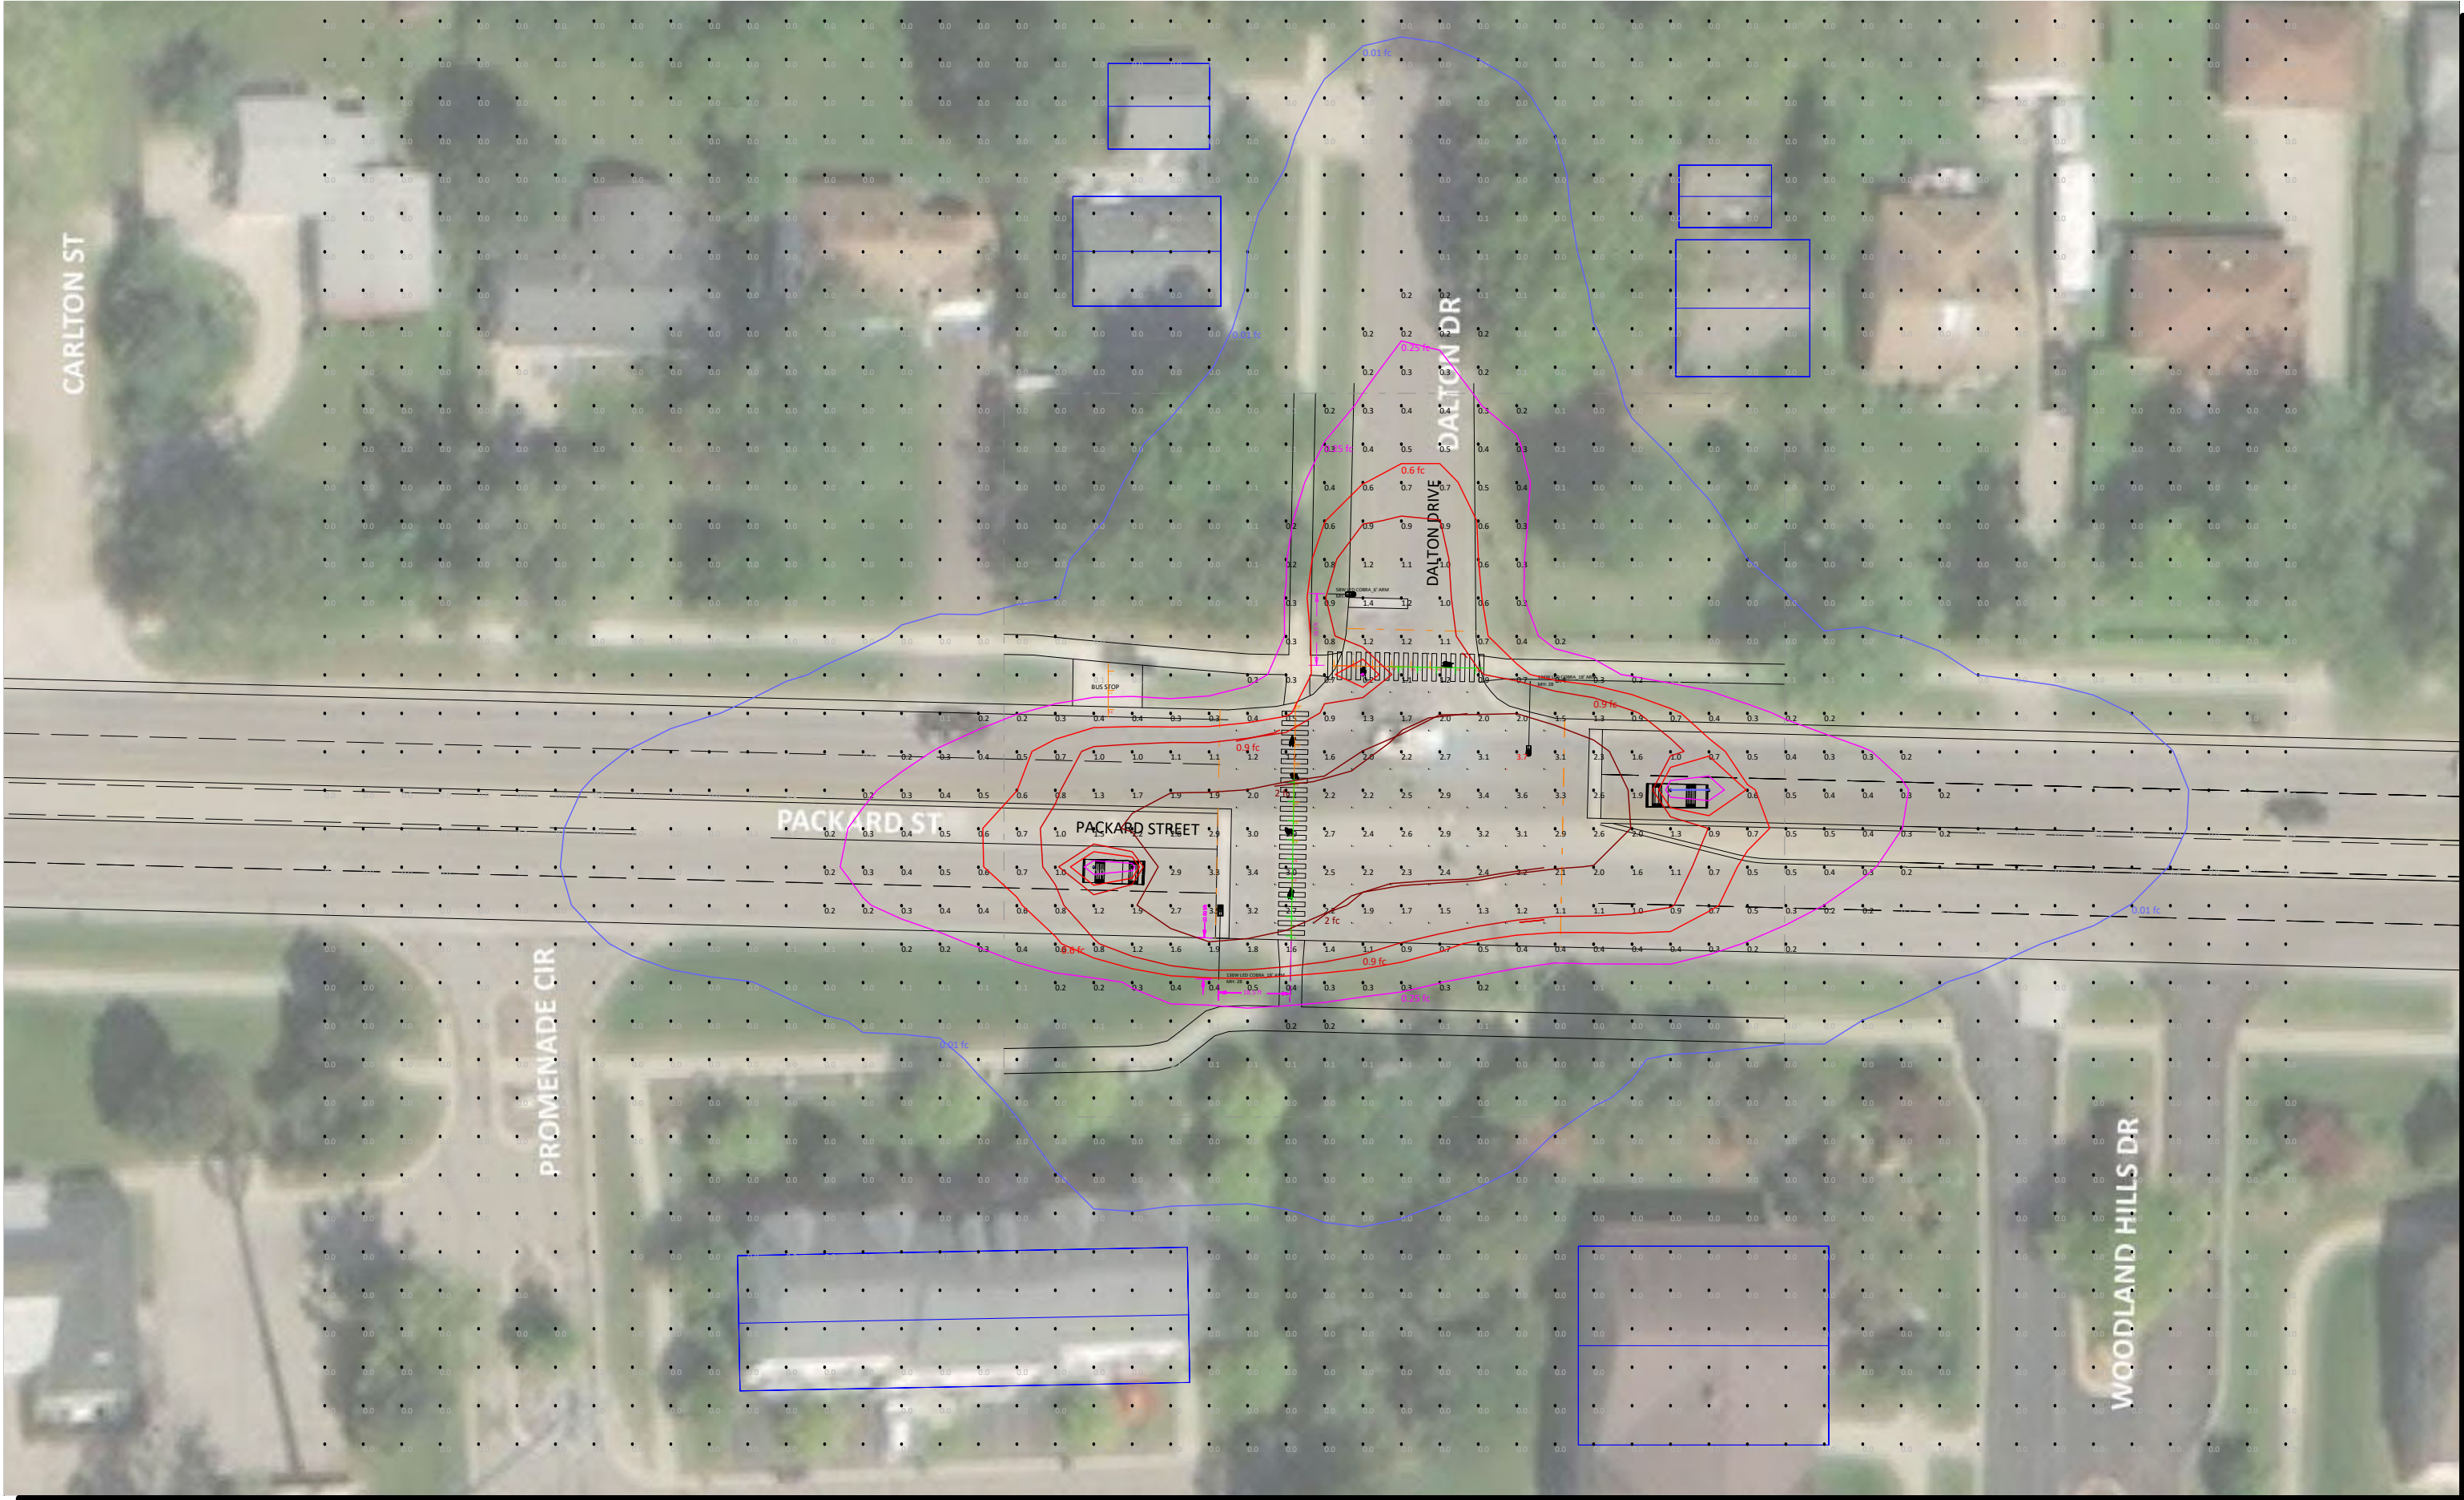


PHOTOMETRIC RESULTS
Scale: 1 inch= 40 Ft.

Numeric Summary								
Label	CalcType	Units	Avg	Max	Min	Avg/Min	Max/Min	Grid Reflect
BUS STOP	Illuminance	Fc	0.20	0.3	0.1	2.00	3.00	N.A.
DALTON- NORTH FLOW - VERTICAL	Illuminance	Fc	0.36	0.4	0.3	1.20	1.33	N.A.
DALTON- SOUTH FLOW - VERTICAL	Illuminance	Fc	1.07	1.2	0.8	1.34	1.50	N.A.
INTERSECTION - HORIZONTAL	Illuminance	Fc	2.15	3.8	0.7	3.07	5.43	N.A.
OVERALL - HORIZONTAL	Illuminance	Fc	0.14	3.7	0.0	N.A.	N.A.	N.A.
PACKARD - EAST FLOW - VERTICAL	Illuminance	Fc	2.30	2.9	1.2	1.92	2.42	N.A.
PACKARD - WEST FLOW - VERTICAL	Illuminance	Fc	1.68	2.1	0.8	2.10	2.63	N.A.


Luminaire Schedule						
Symbol	Qty	Label	Arrangement	Total Lamp Lumens	LLF	Description
—┐	1	58W LED COBRA_6' ARM	SINGLE	N.A.	0.686	GCM2-30H-MV-NW-2R-XX-610
—┐	2	136W LED COBRA_18' ARM	SINGLE	N.A.	0.719	GCL1-80G-MV-NW-2R-XX-530

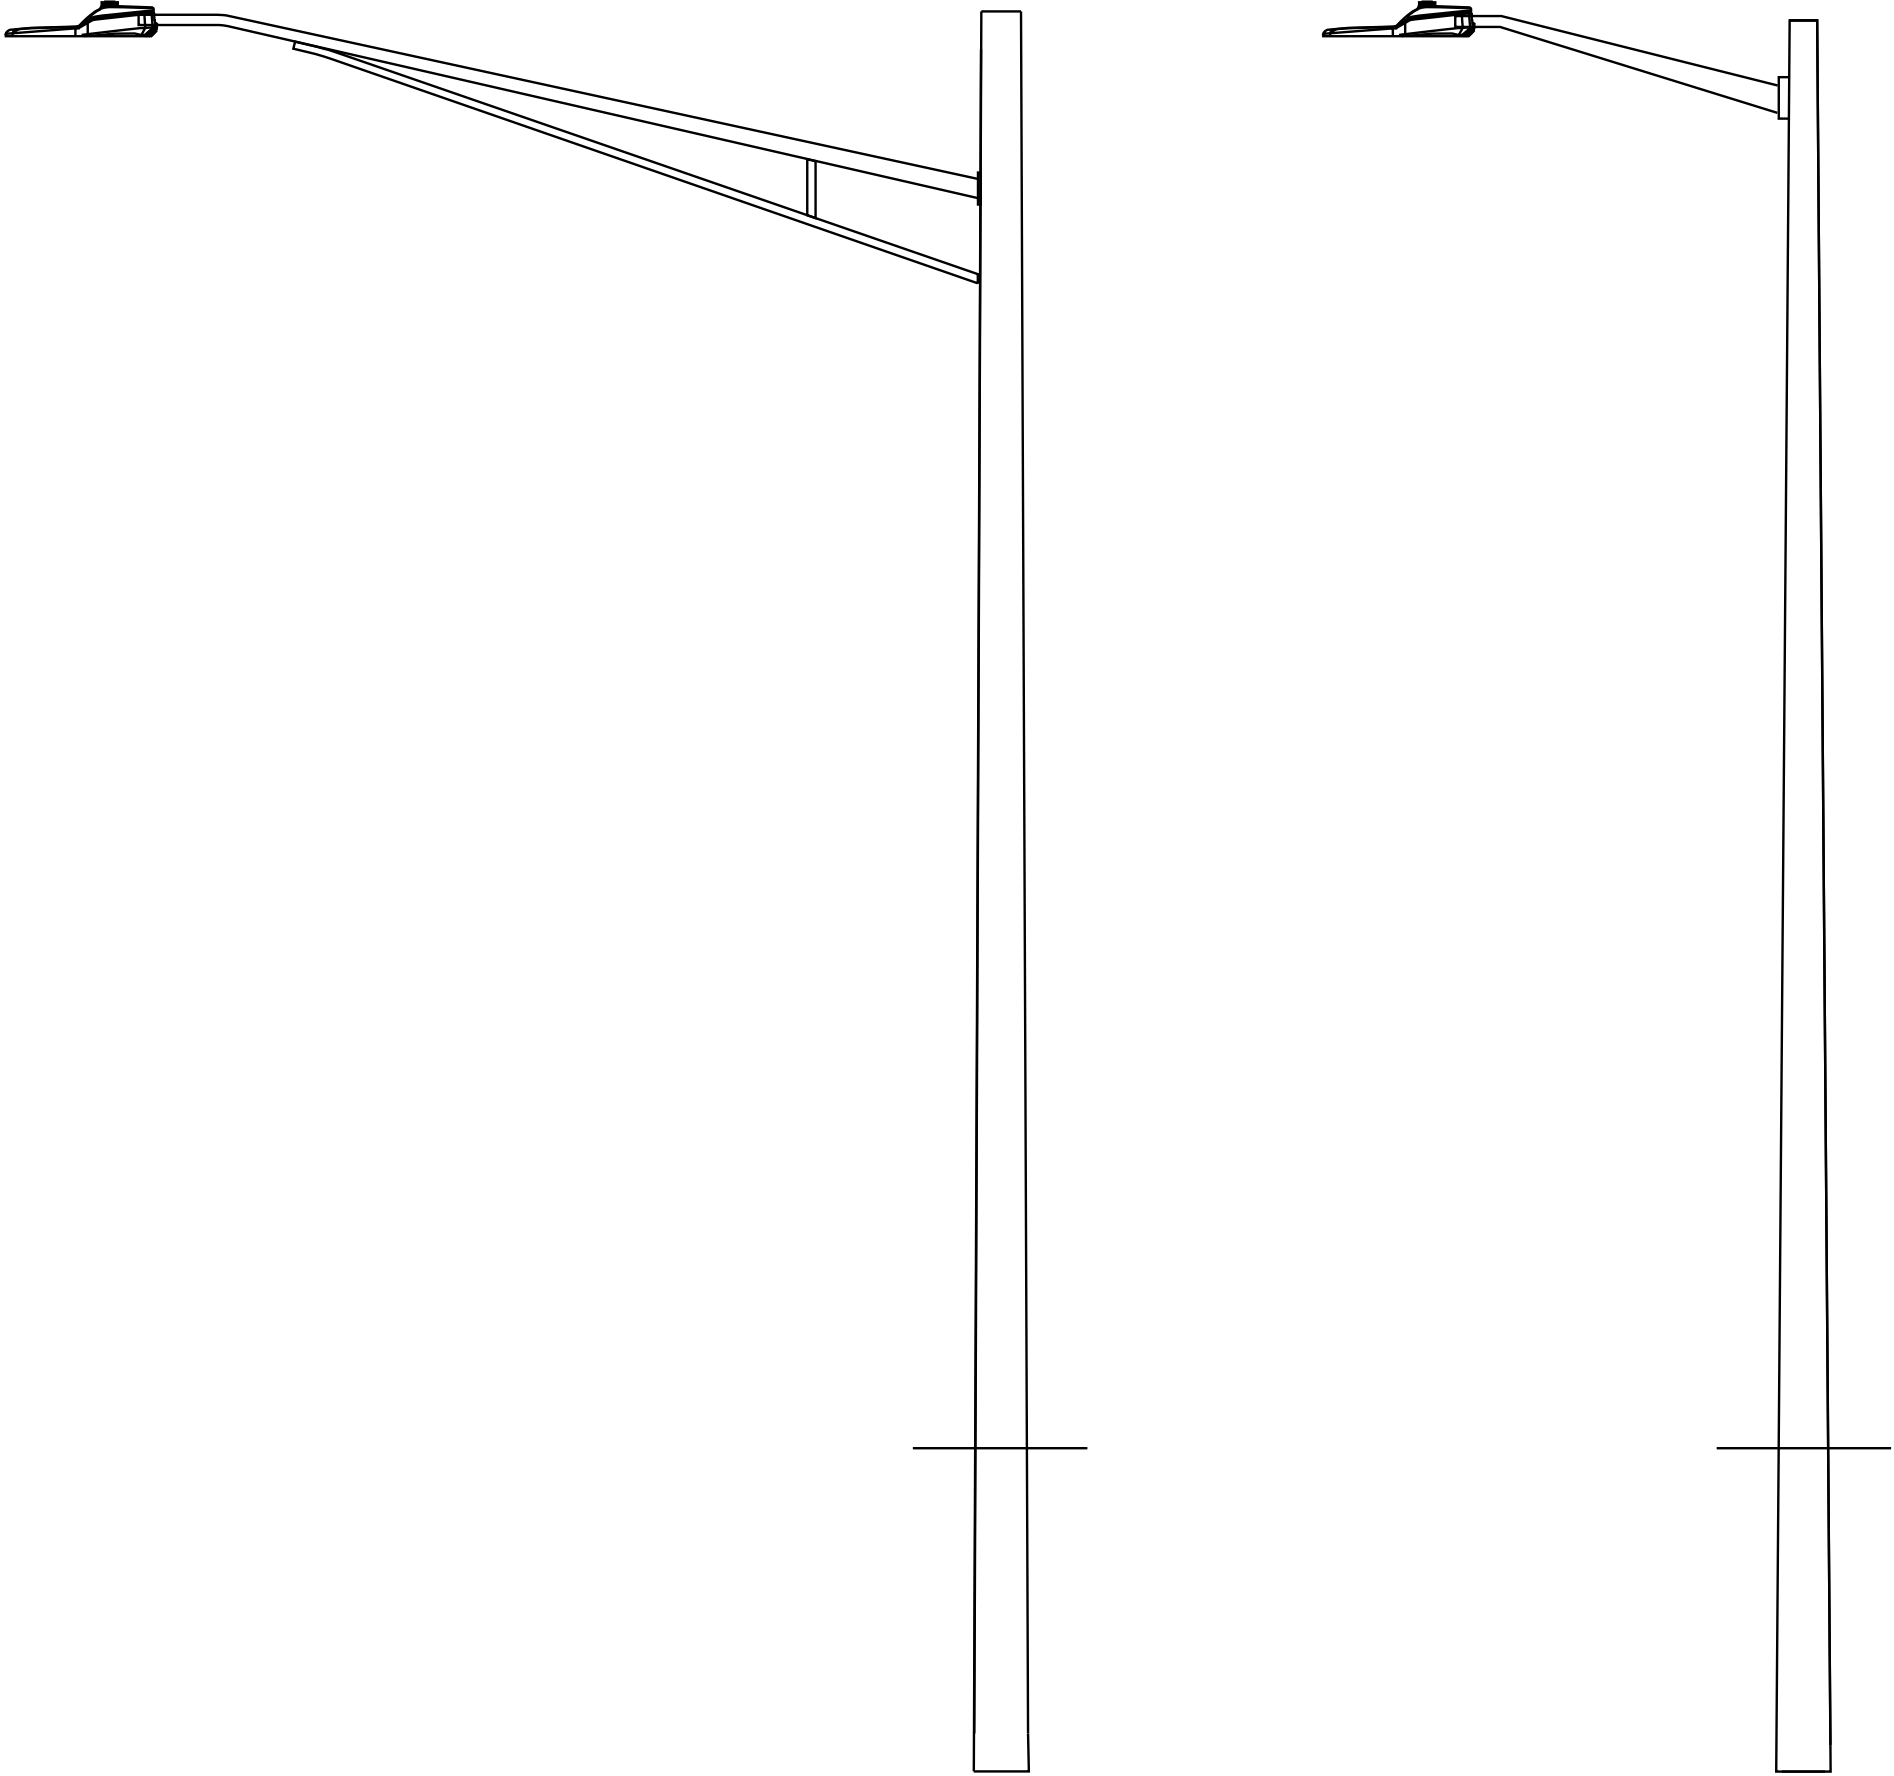

Revisions				
#	Date	Comments		

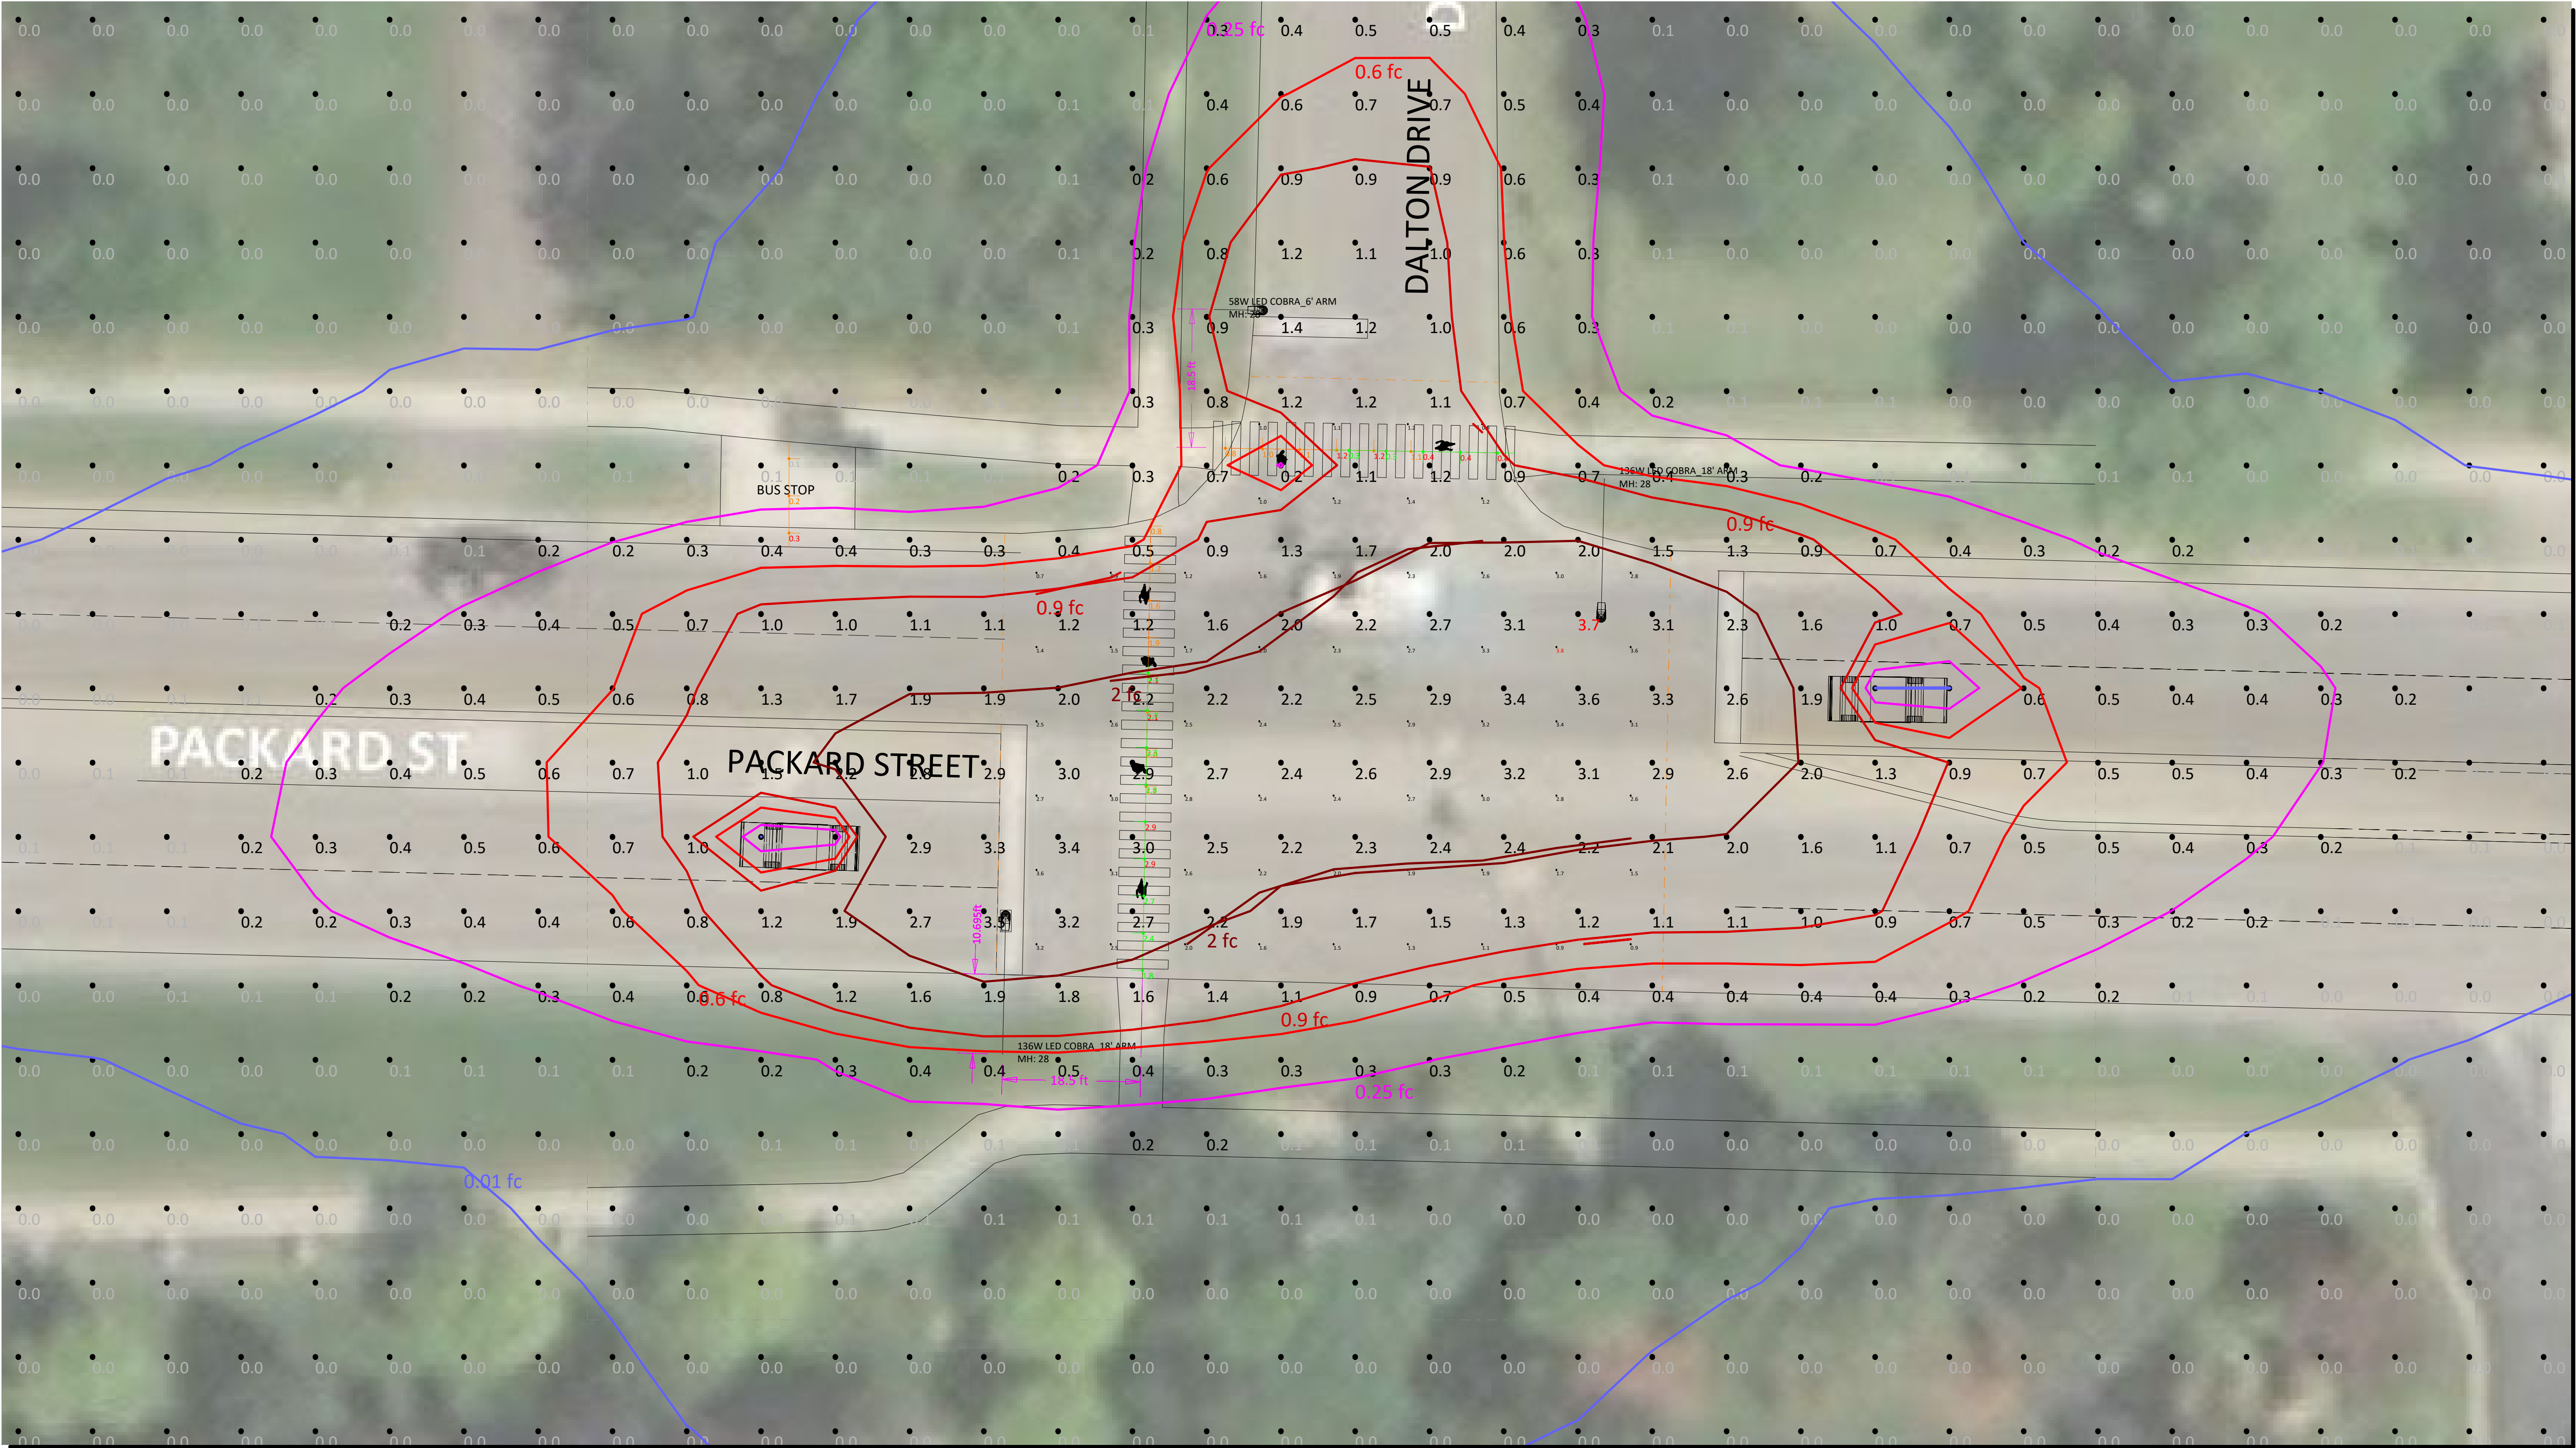


PLAN VIEW
Not to Scale

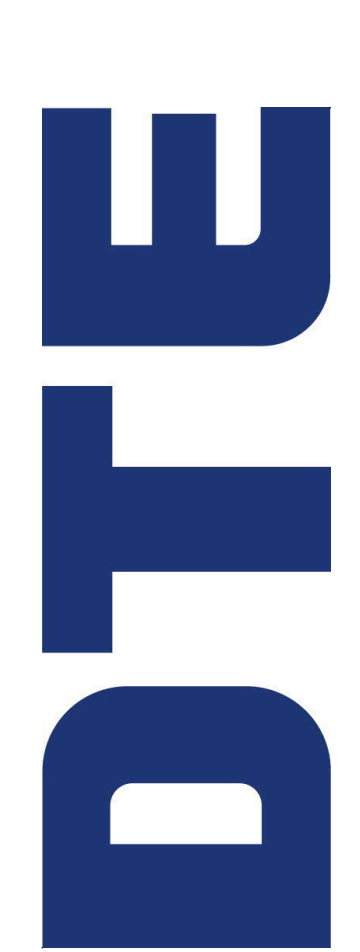

#	Date	Comments
Revisions		

Drawn By: M. Valascho
Checked By:
Date: 12/17/2020
Scale: Not to Scale

DTE Street Lighting Plan 5 (3 LIGHTS)
Packard St & Dalton Dr Intersection

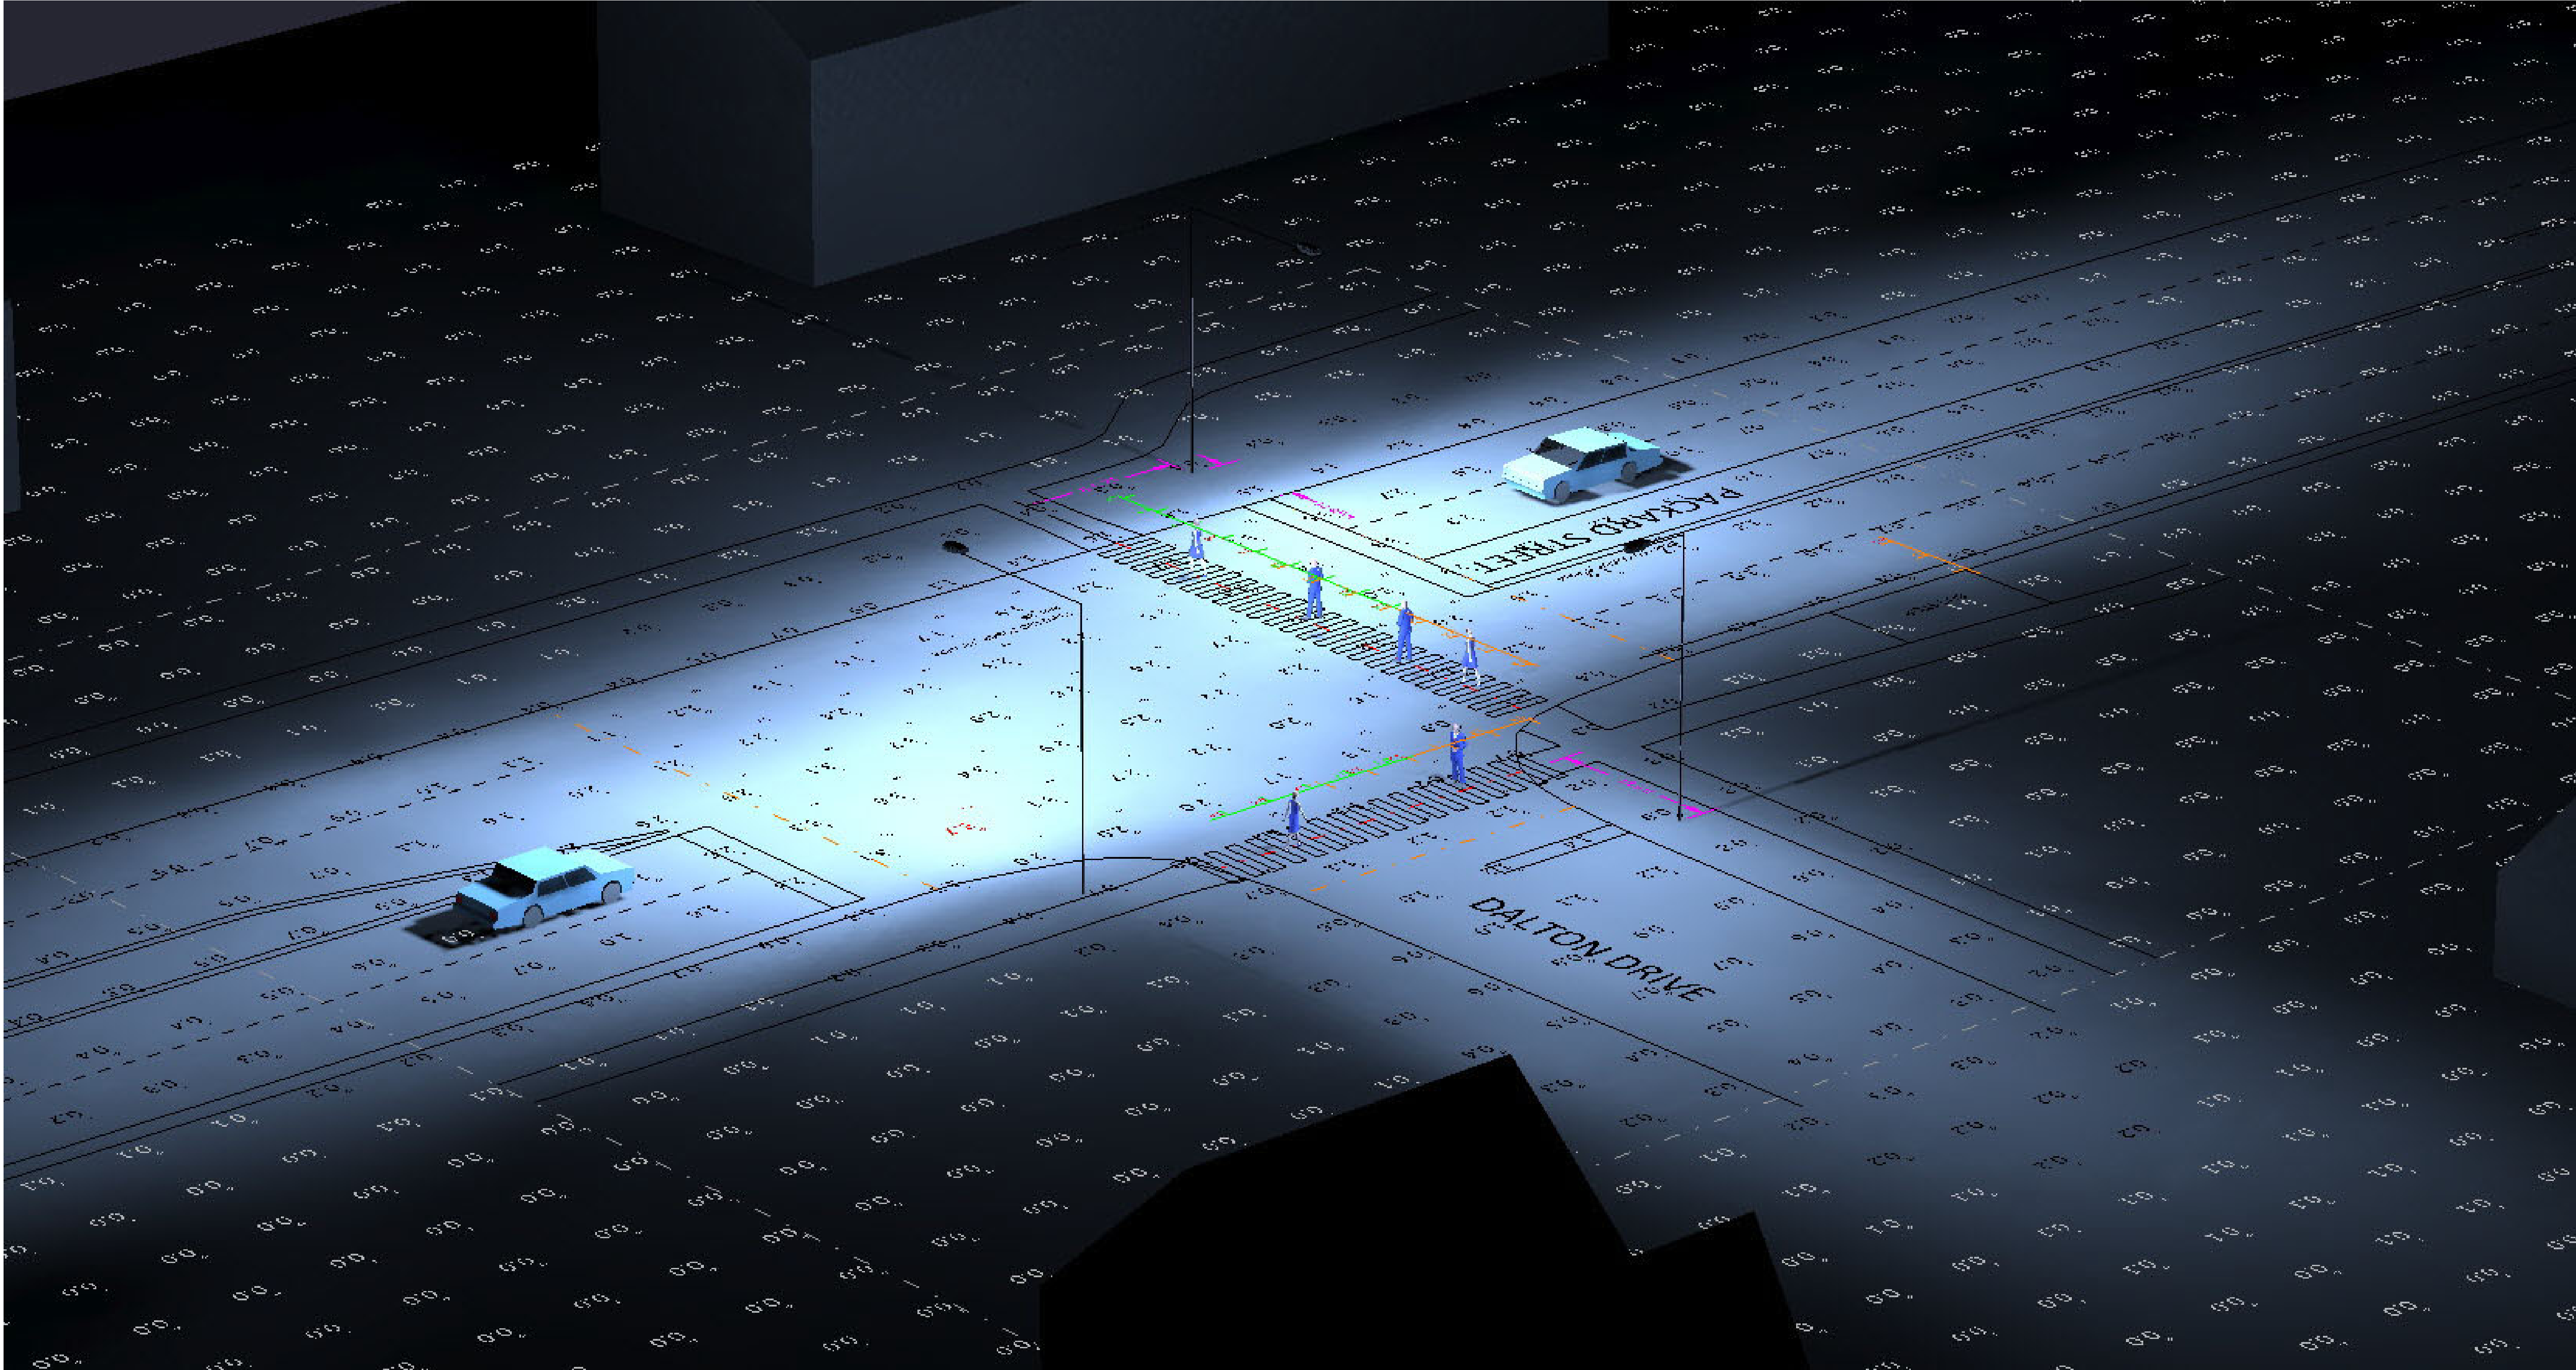


RENDERED - ISOMETRIC VIEW

#	Date	Comments
Revisions		


Drawn By: M. Valascho
Checked By:
Date: 12/17/2020
Scale: Not to Scale

DTE Street Lighting Plan 5 (3 LIGHTS)
Packard St & Dalton Dr Intersection

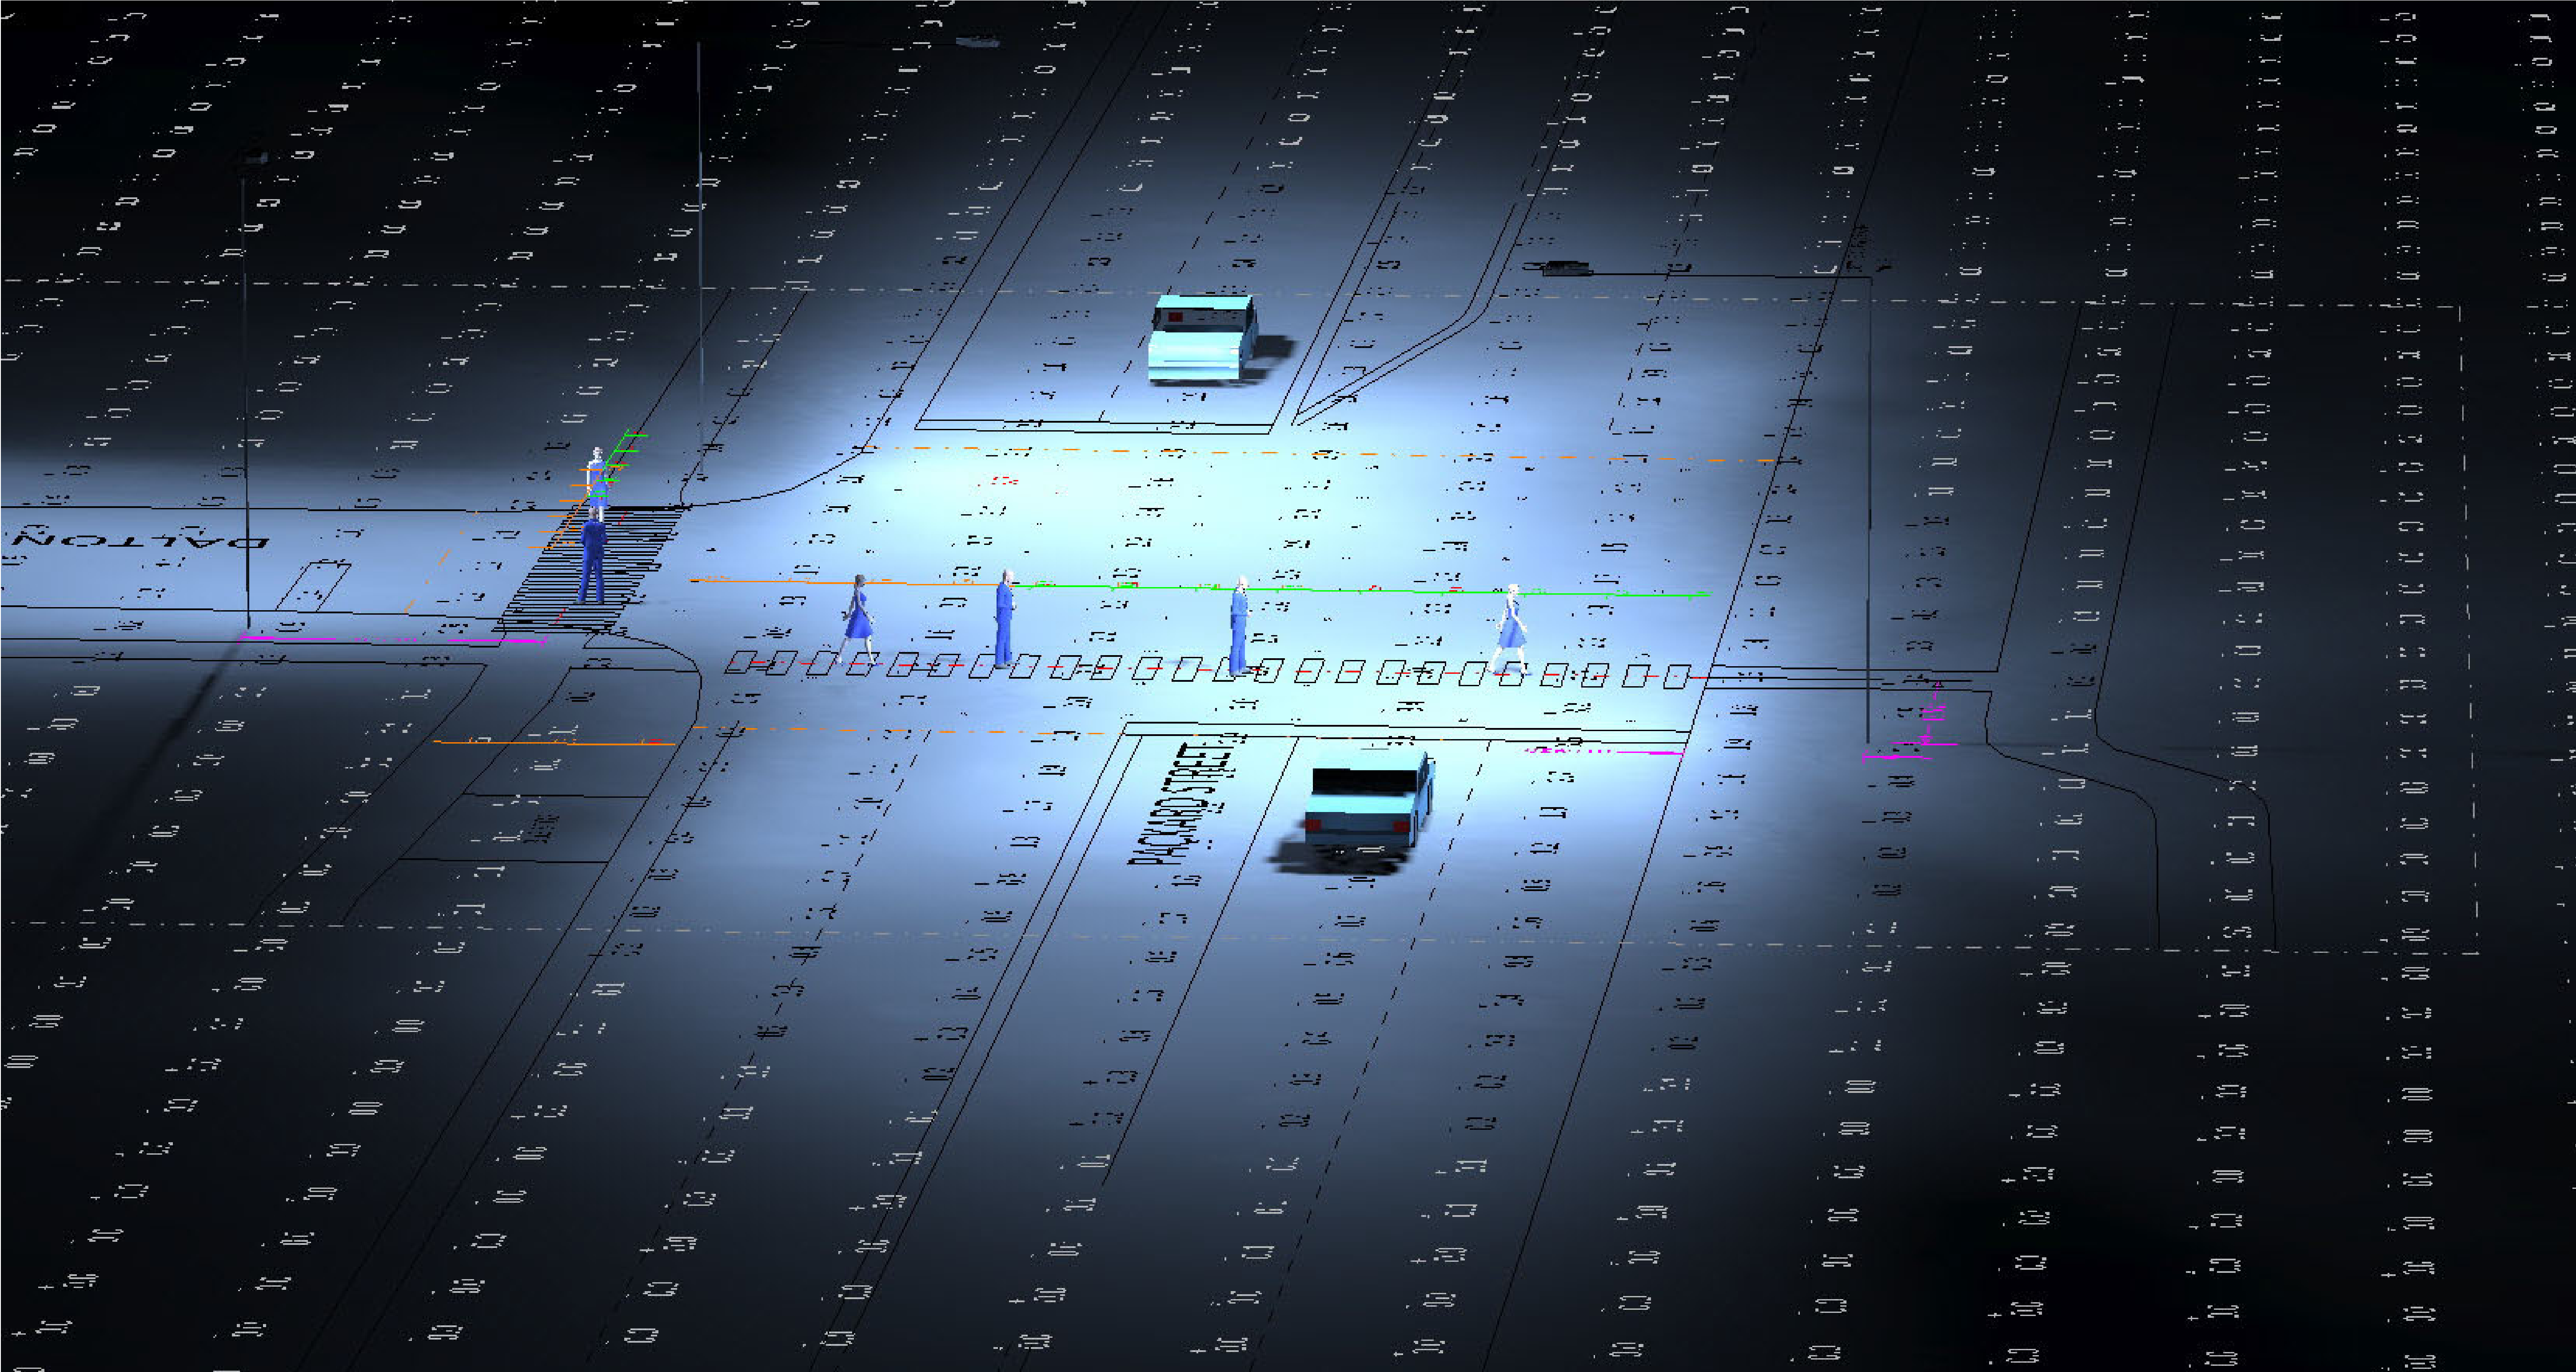

RENDERED - PACKARD ST - EB CROSSWALK

Revisions		Comments	
#	Date		

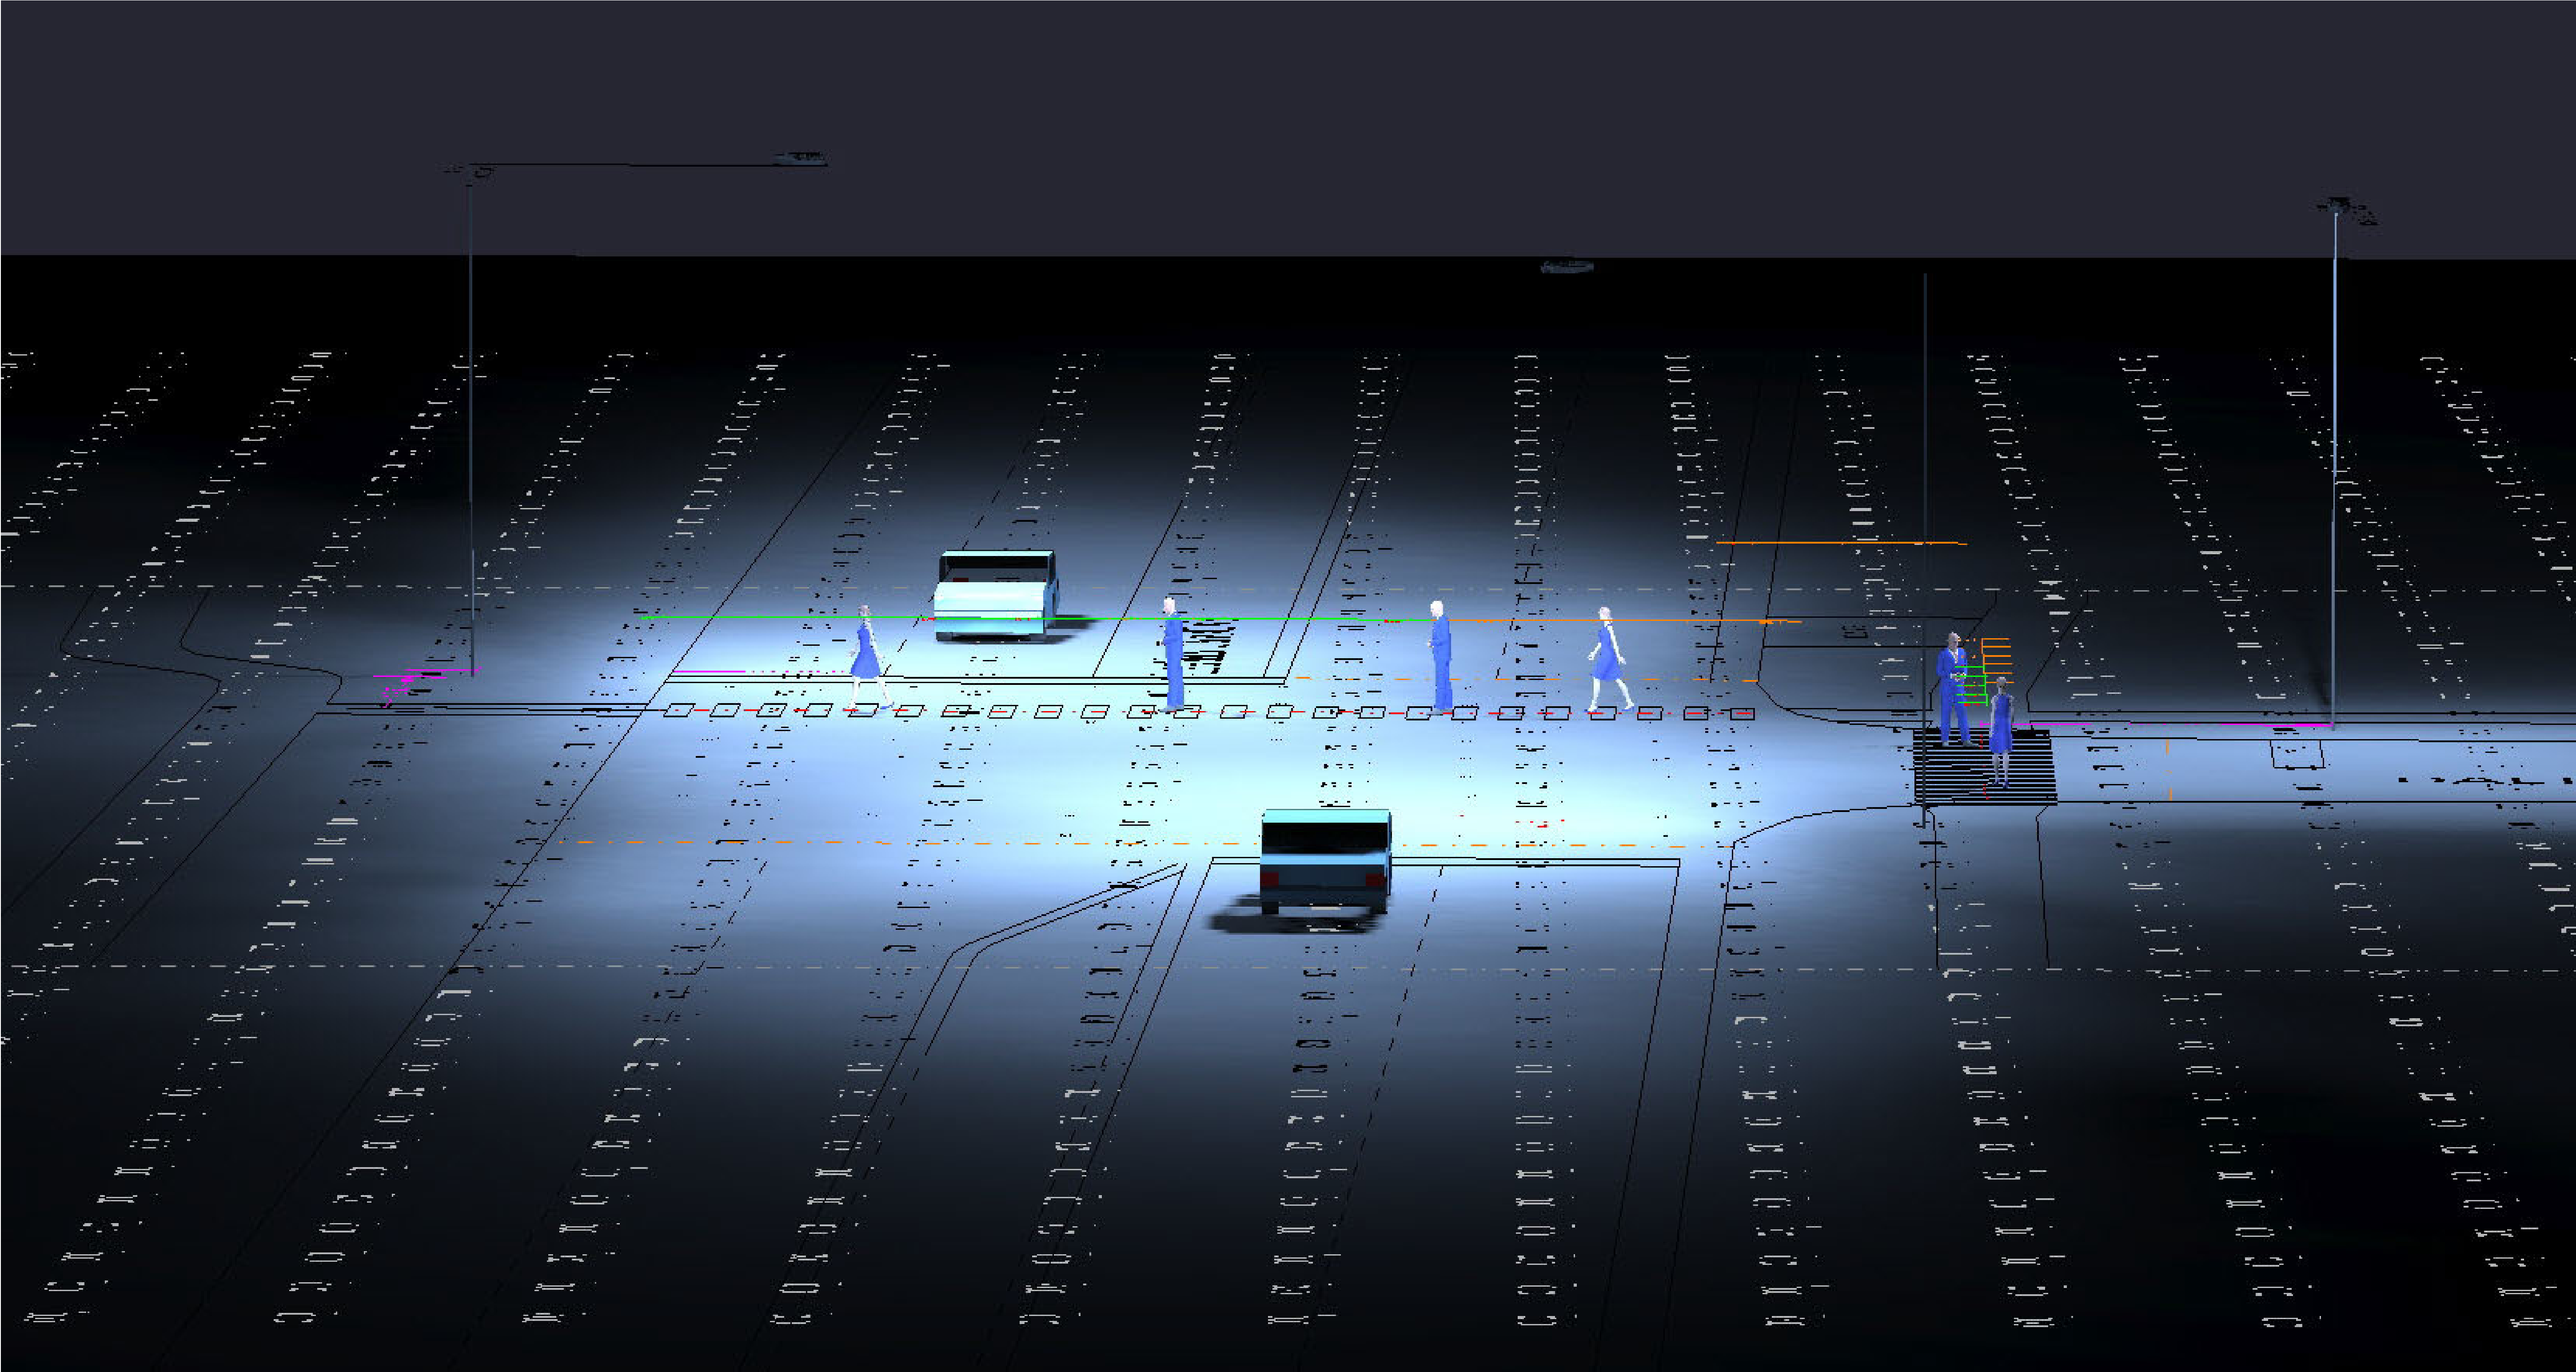


RENDERED - PACKARD ST - WB CROSSWALK

#	Date	Comments
Revisions		

Drawn By: M. Valascho
Checked By:
Date: 12/17/2020
Scale: Not to Scale

DTE Street Lighting Plan 5 (3 LIGHTS)
Packard St & Dalton Dr Intersection

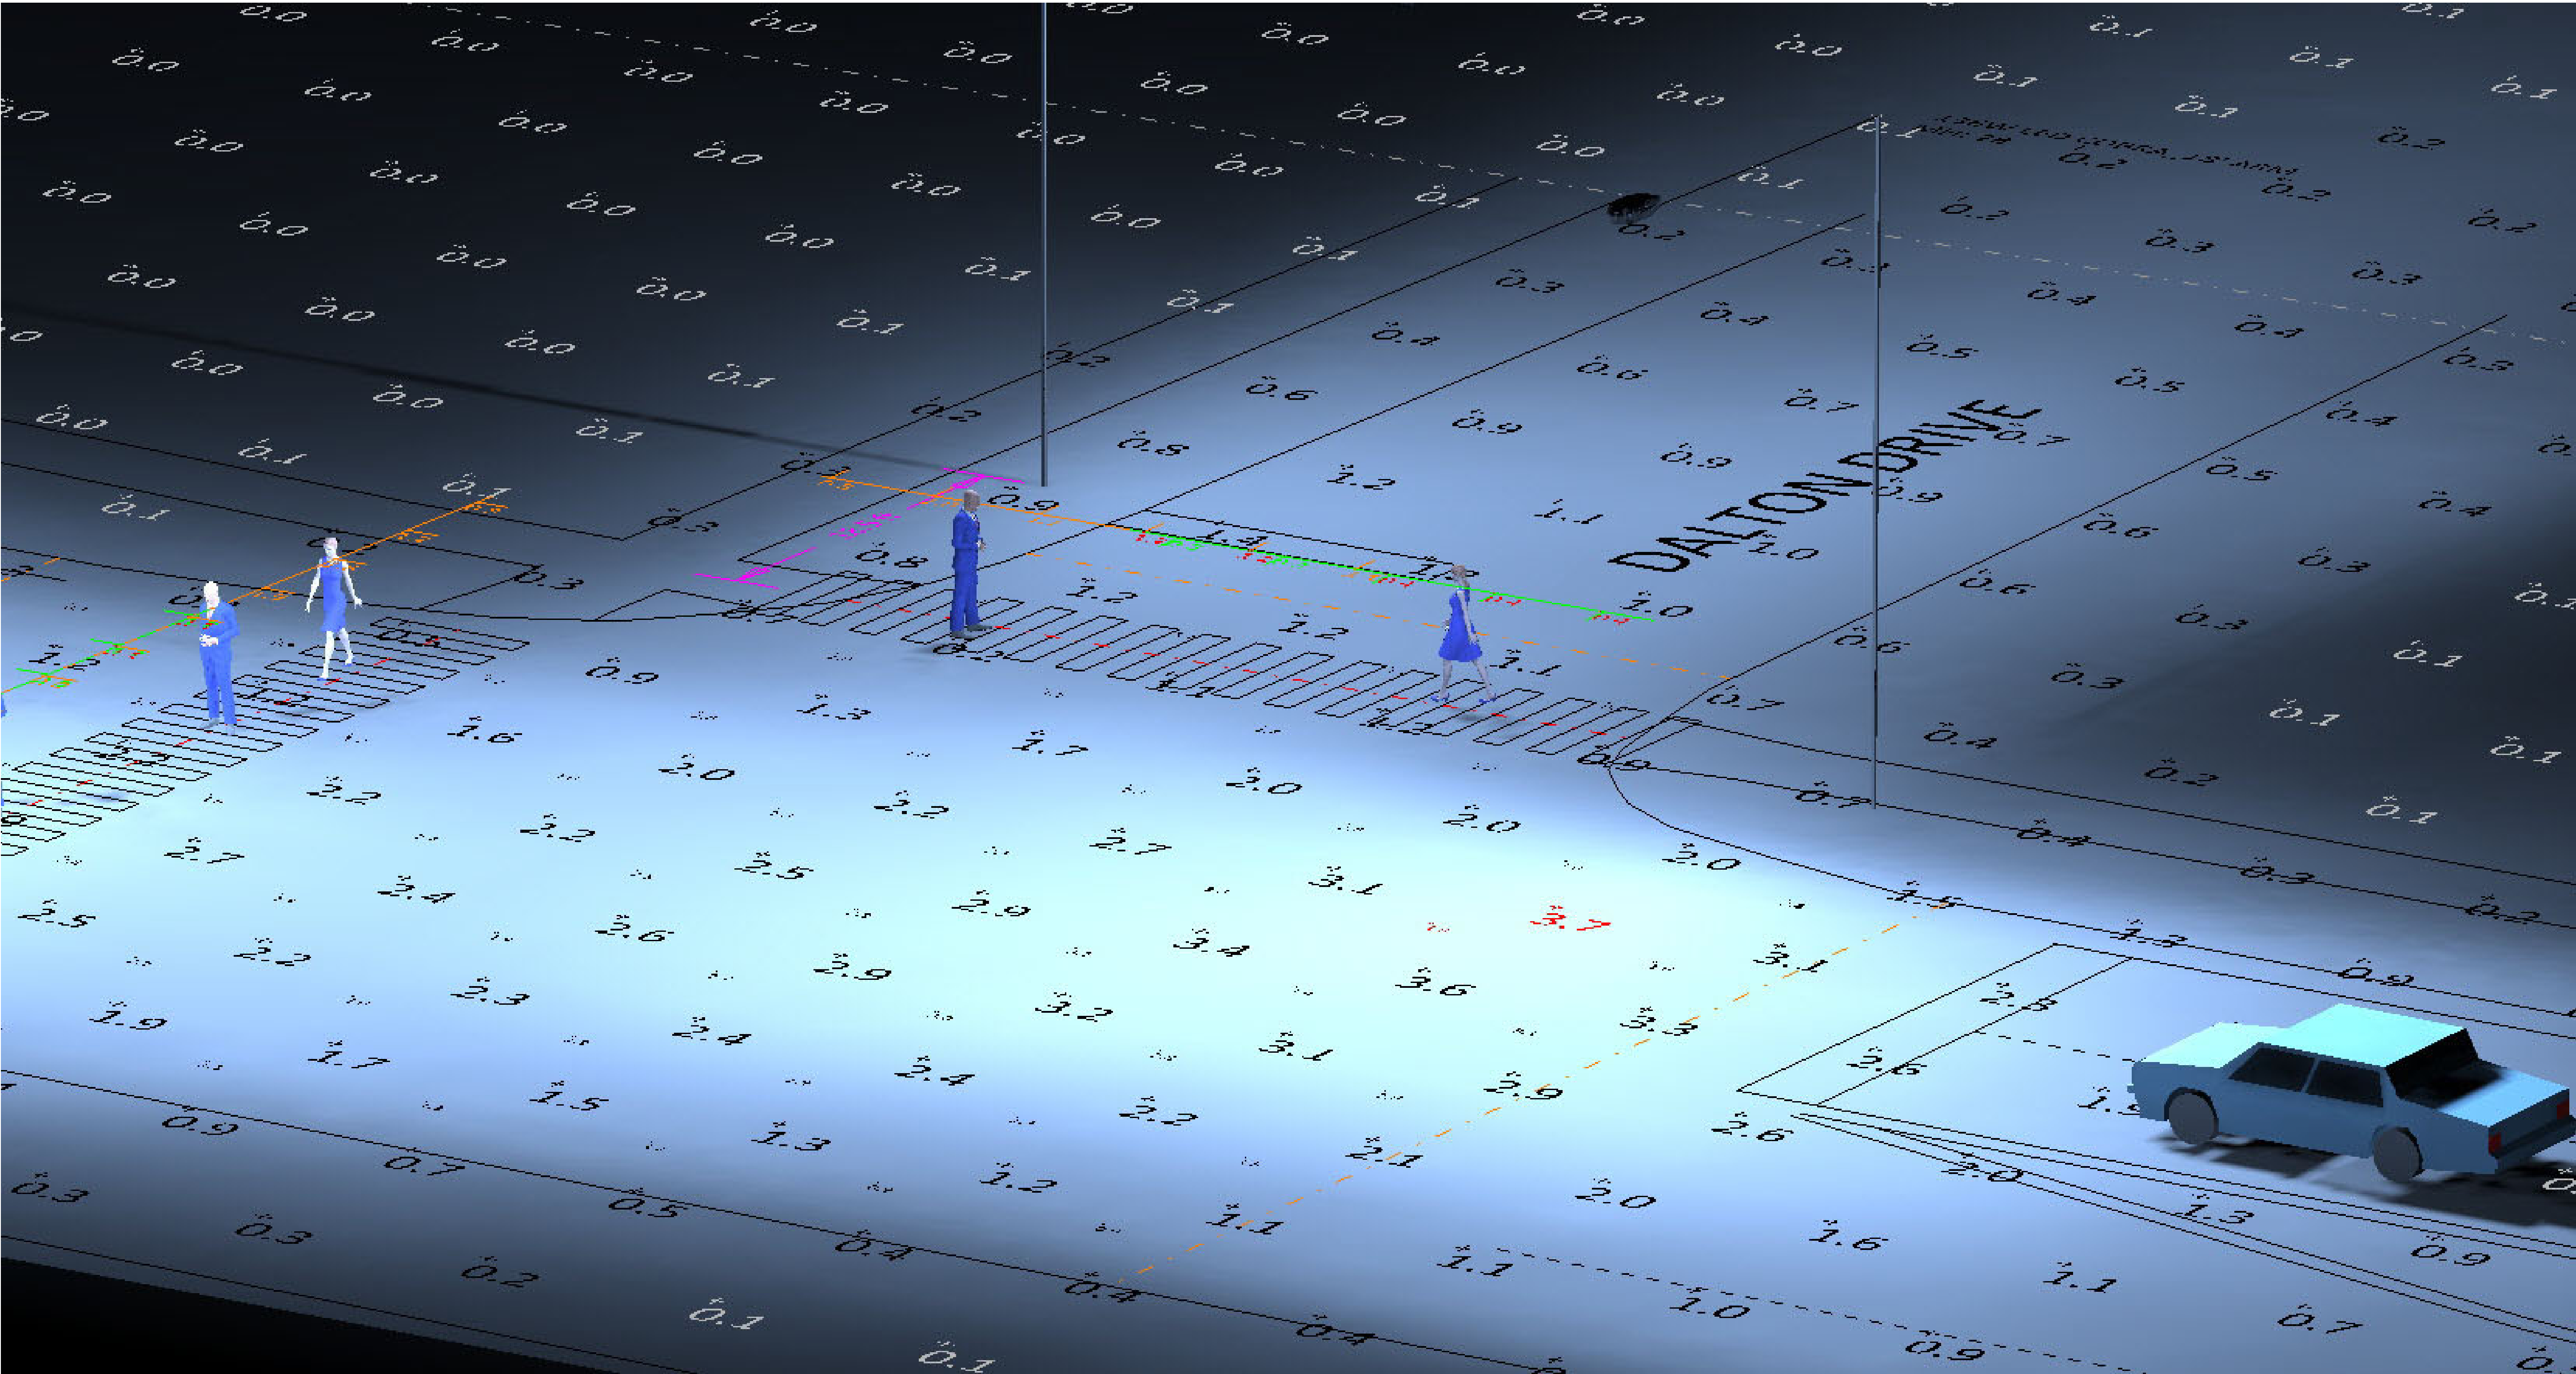


RENDERED - DALTON DR - NB CROSSWALK

Revisions				
#	Date	Comments		

Scale: Not to Scale				
Date: 12/17/2020				
Checked By:				
Drawn By: M. Valascho				

DTE Street Lighting Plan 5 (3 LIGHTS)	
Packard St & Dalton Dr Intersection	

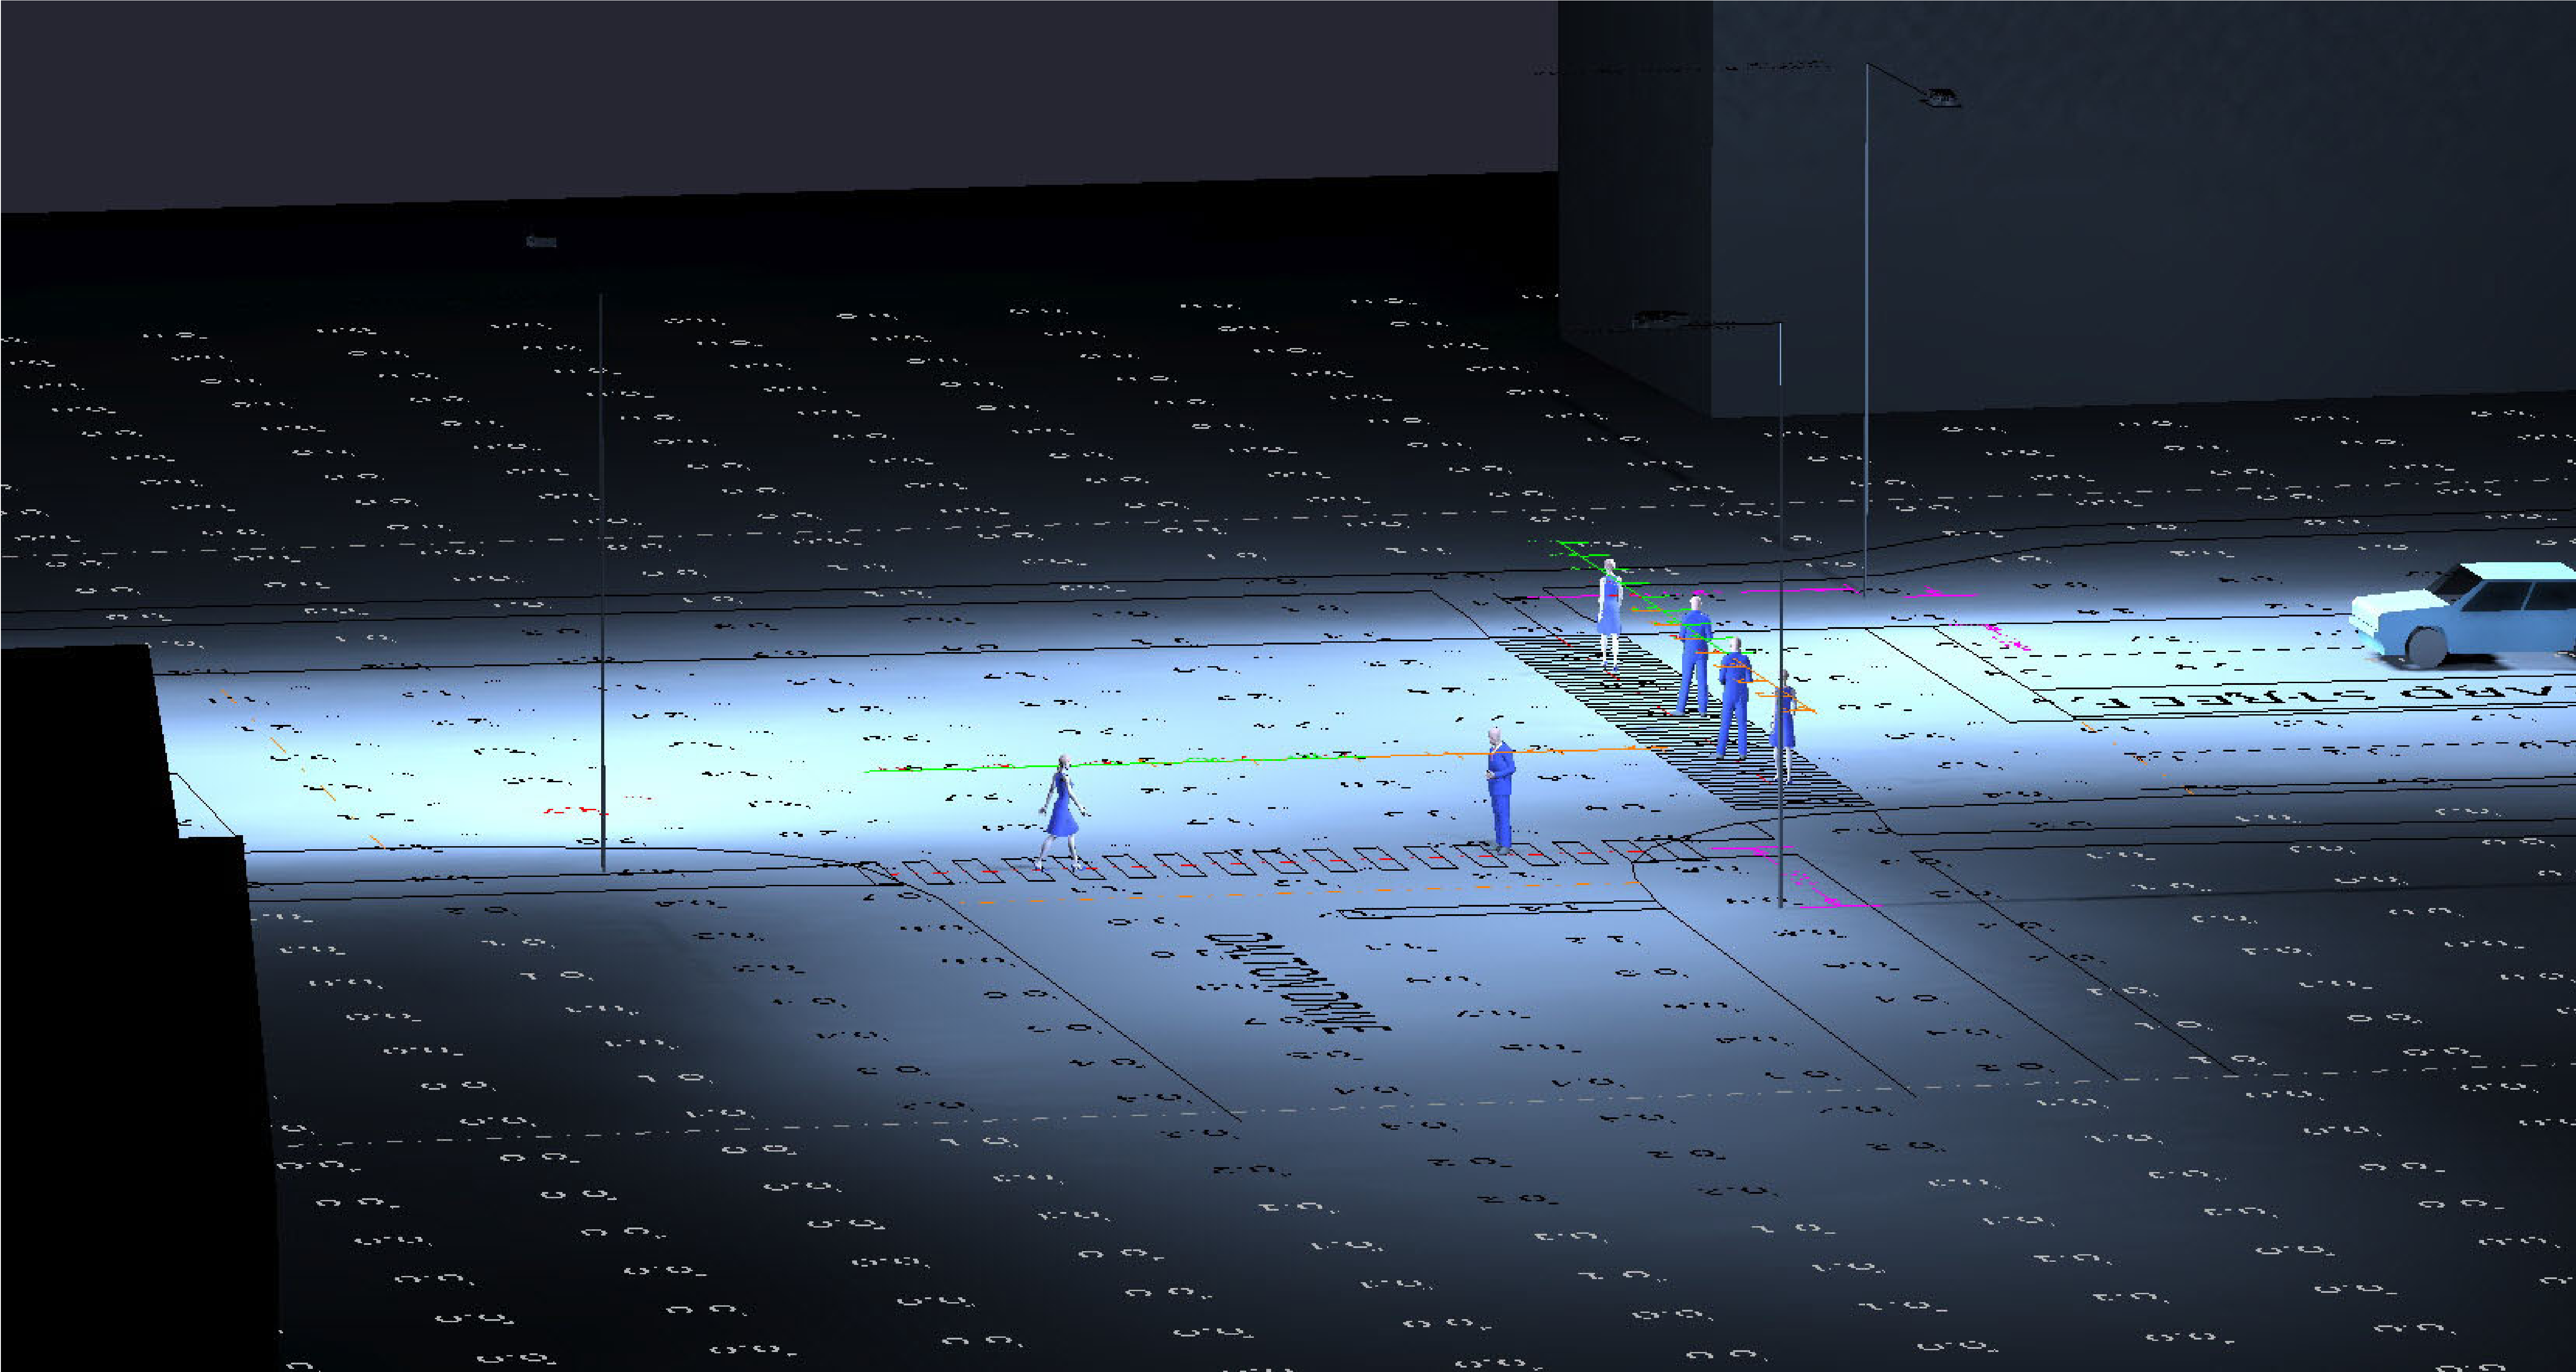

RENDERED - DALTON DR - SB CROSSWALK

#	Date	Comments
Revisions		

Drawn By: M. Valascho
Checked By:
Date: 12/17/2020
Scale: Not to Scale

DTE Street Lighting Plan 5 (3 LIGHTS)
Packard St & Dalton Dr Intersection